


East Lake Sammamish Master Plan Trail, South Sammamish Segment B


SE 33rd Street to Inglewood Hill Road

King County, Washington

CONTRACT NO. XX

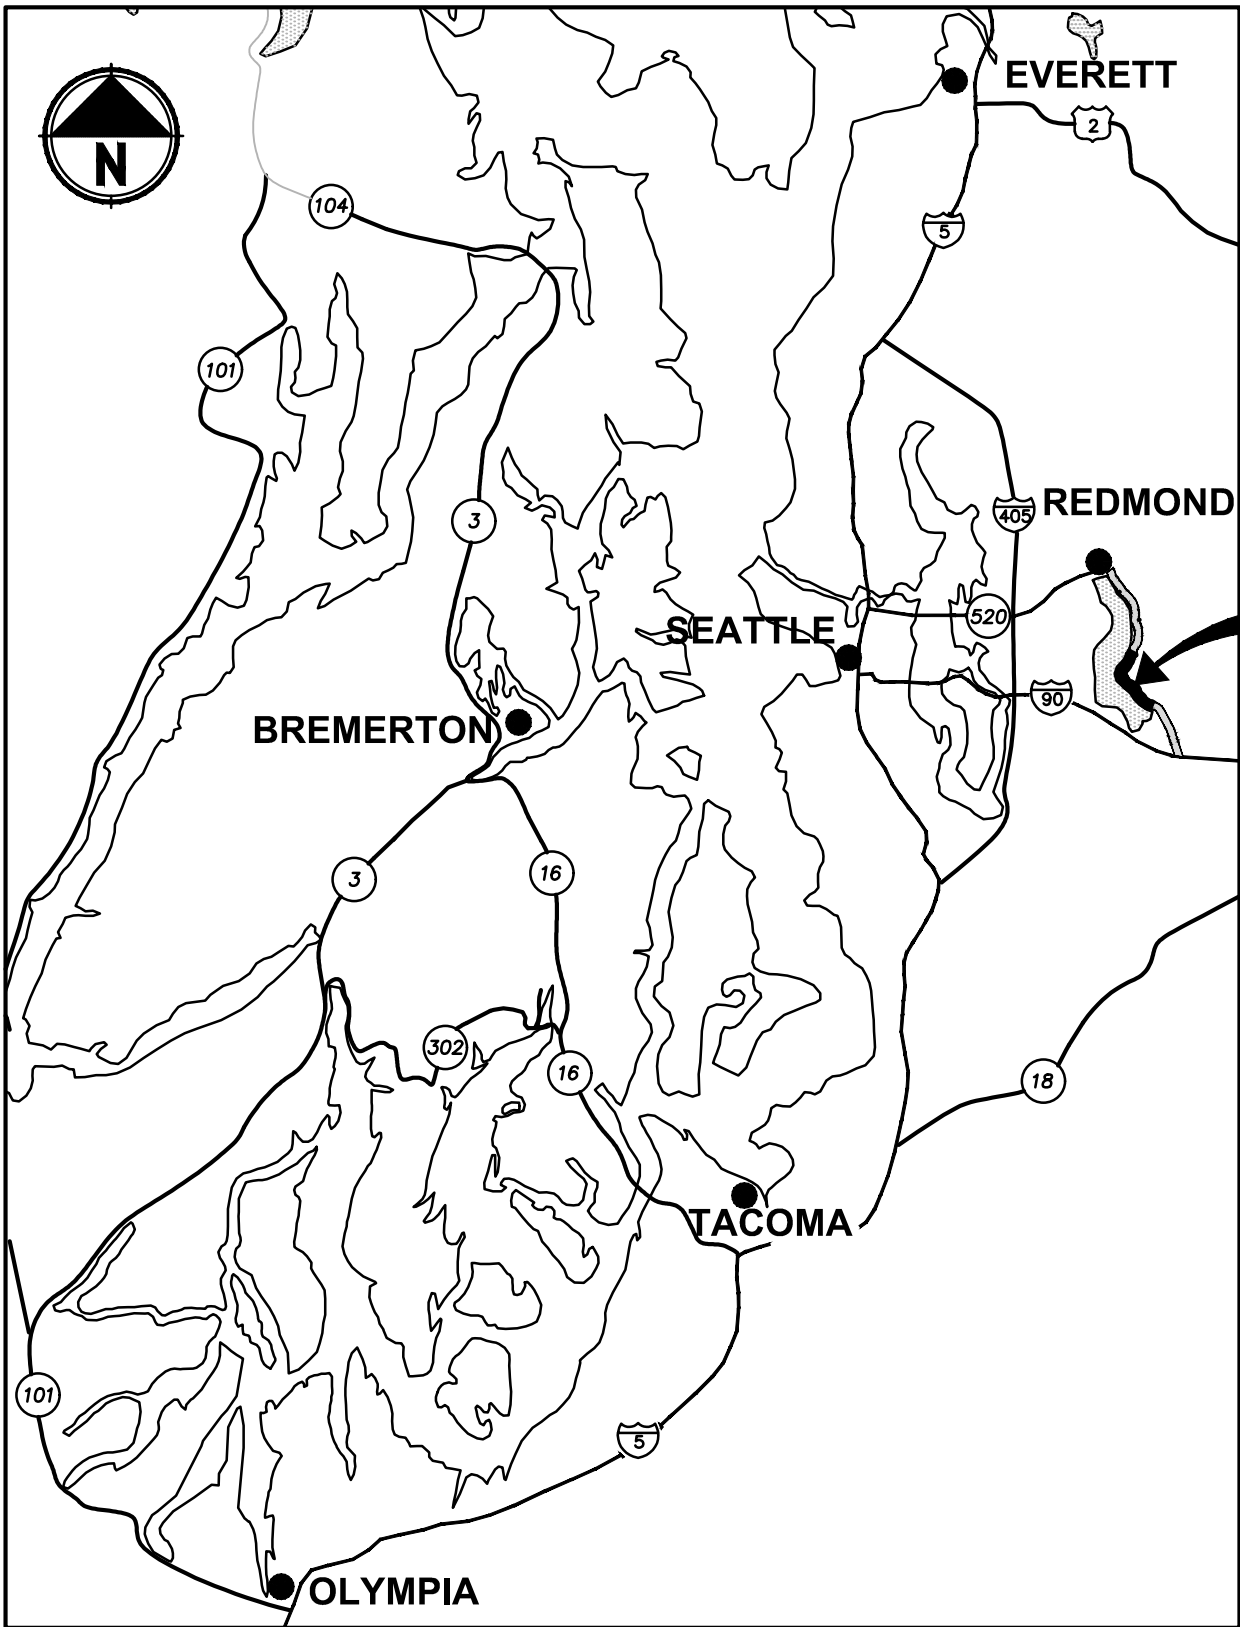

LOCATION MAP
NOT TO SCALE

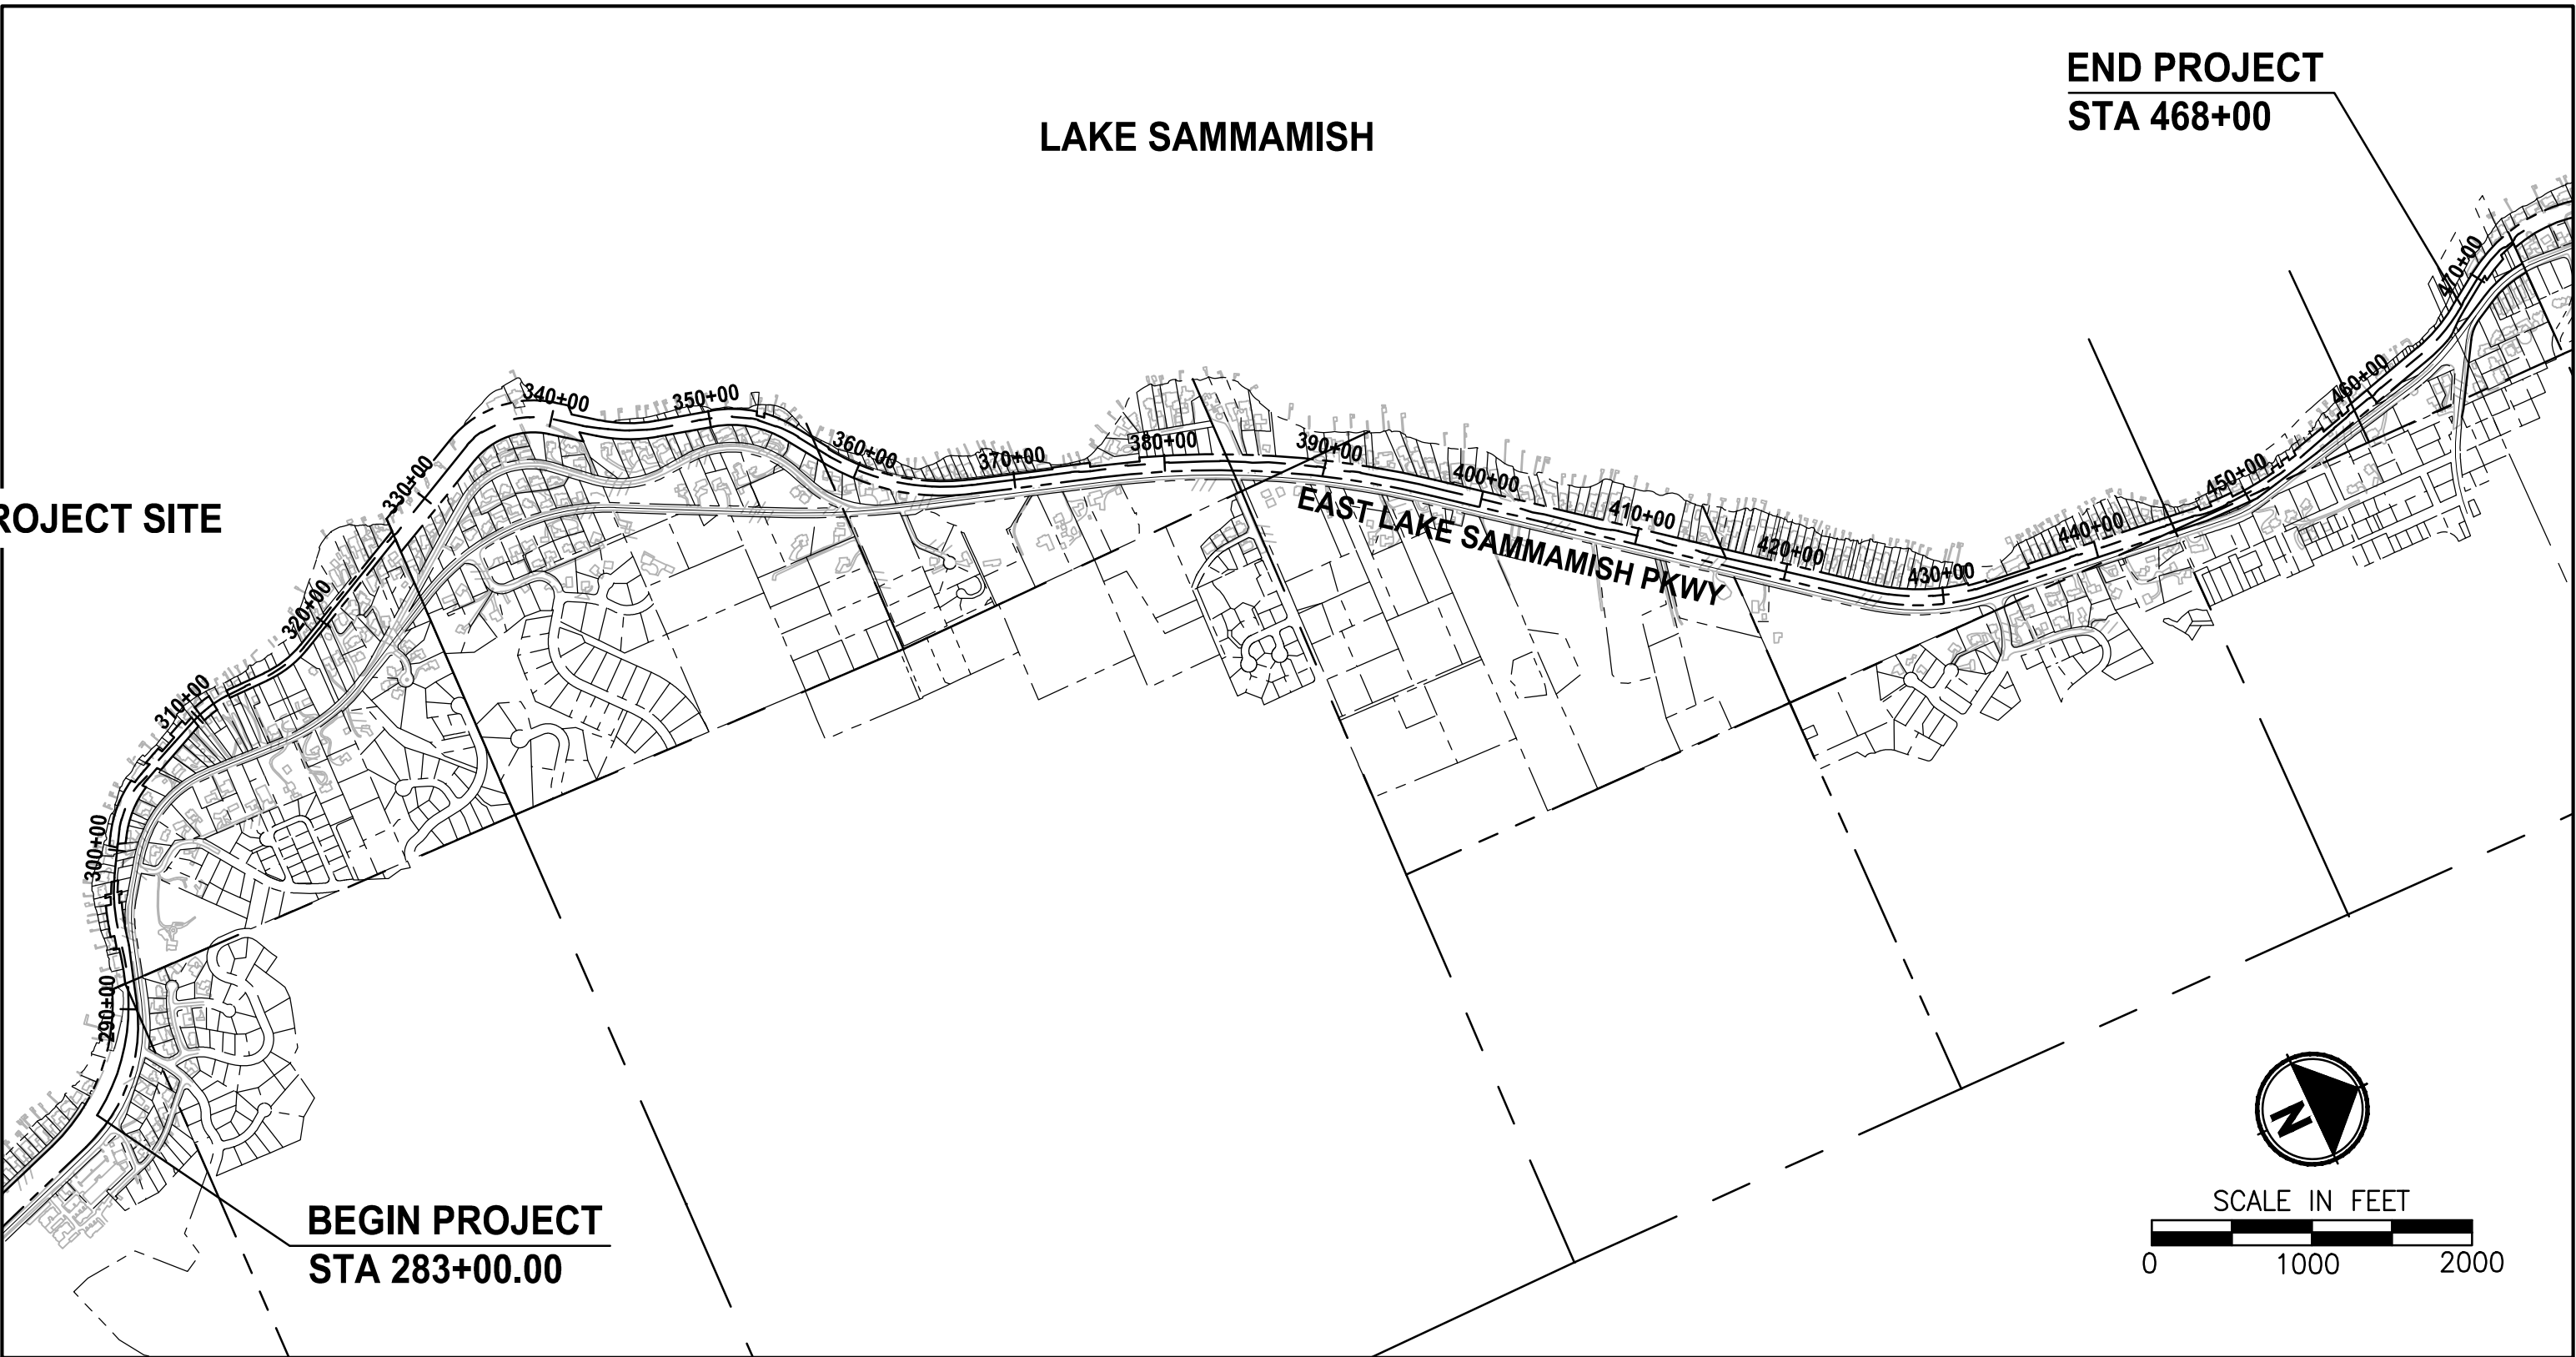

VICINITY MAP

RIGHT OF WAY NOTE:

RIGHT OF WAY LINES SHOWN ARE BASED ON KING COUNTY MAP VAULT SURVEY OF EAST LAKE SAMMAMISH TRAIL, MAP NUMBER 311-99, DATED AUGUST 8TH, 1998, WITH SUBSEQUENT CONVEYANCES AND EASEMENTS BEING UPDATED ACCORDING TO AUDITOR DOCUMENTS OF RECORD.

PROPERTY INFORMATION:

PARCEL NUMBERS:	2925069007 (11.13 ACRES)
	082406-9214 (9.16 ACRES)
	072406-9119 (0.08 ACRE)
	072406-9039 (0.22 ACRE)
	072406-9040 (0.12 ACRE)
	072406-9036 (0.27 ACRE)
	406510-0005 (0.48 ACRE)
	406510-0011 (0.10 ACRE)
	072406-9033 (0.27 ACRE)
	322506-9015 (13.79 ACRES)
	062406-9013 (15.19 ACRES)
	072406-9004 (2.16 ACRES)

PROJECT & SITE INFORMATION:

KING COUNTY PROPOSES TO DEVELOP AN ALTERNATIVE TRANSPORTATION CORRIDOR AND RECREATION TRAIL ALONG 3.5 MILES OF A FORMER RAILROAD CORRIDOR IN THE CITY OF SAMMAMISH, LOCATED BETWEEN ISSAQUAH/SAMMAMISH CITY LIMIT AND INGLEWOOD HILL ROAD. A GRAVEL INTERIM TRAIL IS CURRENTLY IN OPERATION.

DISTURBED AREA = 9.5 AC
EXISTING IMPERVIOUS AREA = 5.3 AC
PROPOSED IMPERVIOUS AREA = 8.4 AC
VOLUME OF ESTIMATED FILL = 4,520 CY
VOLUME OF ESTIMATED EXCAVATION = 7,200 CY

WRITTEN DESCRIPTION OF THE PROJECT:

THE EXISTING GRAVEL TRAIL WILL BE WIDENED TO 12 FEET AND PAVED WITH 2-FOOT GRAVEL SHOULDERS ON BOTH SIDES.

THE PROPOSED IMPROVEMENTS INCLUDE RETAINING WALLS, DRAINAGE IMPROVEMENTS, FENCE, SIGNS AND MITIGATION FOR IMPACTS TO WETLANDS AND WETLAND AND STREAM BUFFERS.

EXISTING ZONE CLASSIFICATION:

COMMUNITY FACILITIES CF-F

EXISTING SHORELINE ENVIRONMENT DESIGNATION:

CITY OF SAMMAMISH DESIGNATION: SHORELINE RESIDENTIAL

GENERAL PURPOSE OF THIS PROJECT:

TO DEVELOP AN ALTERNATIVE TRANSPORTATION CORRIDOR IN A FORMER RAILROAD CORRIDOR.

CONTACT INFORMATION:

APPLICANT/OWNER:
KING COUNTY PARKS AND RECREATION DIVISION
201 S. JACKSON, 7TH FLR
SEATTLE, WA 98104
(206) 263-7283
CONTACT: GINA AULD

ENGINEER:
PARAMETRIX
719 2ND AVENUE
SUITE 200
SEATTLE, WA 98104
(206) 394-3700
CONTACT: YAMMIE HO, P.E.

UTILITY:
ONE-CALL 1 (800) 424-5555

SAMMAMISH PLATEAU WATER AND SEWER DISTRICT
(425) 295-3203
CONTACT: KYLE WONG

COMCAST CABLE
(425) 263-5348/(425) 319-4968
CONTACT: JOSEPH FORDON

FRONTIER COMMUNICATIONS NW INC.
(425) 261-6342/(425) 210-2870
CONTACT: THOMAS PACEY

PUGET SOUND ENERGY (POWER AND POLE)
(425) 417-9188
CONTACT: DENNIS BOOTH

PUGET SOUND ENERGY (GAS)
(425) 449-7410/(425) 463-6550
CONTACT: JEANNE COLEMAN

EASTSIDE FIRE/RESCUE
(425) 313-3203
CONTACT: GREG TRYON

SURVEYOR:
PARAMETRIX
719 2ND AVENUE
SUITE 200
SEATTLE, WA 98104
(206) 394-3700
CONTACT: DANIEL THIBODEAU

ARBORIST:
AMERICAN FOREST MANAGEMENT, INC
11415 NE 128TH ST SUITE 110
KIRKLAND, WA 98034
(425) 820-3420
CONTACT: BOB LAYTON

SSDP2016-00415

CITY OF SAMMAMISH APPROVAL	
City Engineer	Date
Community Development	Date

90 % REVIEW SUBMITTAL
NOT FOR CONSTRUCTION

COVER SHEET

SHEET NO.
1 OF 274


G1

LAYOUT: G2
PATH: U:\PSO\Projects\Clients\1521-KingCo\554-1521-075-ELST\995vcs\CADD\Phase 19\T03 Civil\Draw\ PLOTTED BY: purgabut DATE: Wednesday, February 27, 2019 6:44:39 PM

ABBREVIATIONS:

AC	ASBESTOS CEMENT PIPE	MIN	MINIMUM
ACP	ASPHALT CONCRETE PAVEMENT	MON	MONUMENT
ADS	ADVANCED DRAINAGE SYSTEMS	MPE	MEDIUM DENSITY POLYETHYLENE PIPE
APPROX	APPROXIMATE	N	NORTH, NORTHING
BOC	BACK OF CURB	N.I.C.	NOT IN CONTRACT
BTM	BOTTOM	NST	NOT STEEPER THAN
BOW	BOTTOM OF WALL	PC	POINT OF CURVE
BVCE	BEGIN VERTICAL CURVE ELEVATION	PE, PEP	POLYETHYLENE PIPE
BVCS	BEGIN VERTICAL CURVE STATION	PT	POINT OF TANGENT
CB	CATCH BASIN	P/L	PROPERTY LINE
C&G	CURB AND GUTTER	PRO	PROPOSED
C/L, CL	CENTERLINE	PUD	PUBLIC UTILITY DISTRICT
CO	CLEANOUT	PVC	POLYVINYL CHLORIDE PIPE
COM	COMMUNICATION	PVI	POINT OF VERTICAL INTERSECTION
CONC	CONCRETE	PWR	POWER
CORR	CORRUGATED	RCP	REINFORCED CONCRETE PIPE
COS	CITY OF SAMMAMISH	REINF	REINFORCED
CONST	CONSTRUCTION	ROW, R/W	RIGHT-OF-WAY
CMP	CORRUGATED METAL PIPE	RT	RIGHT
CP	CONCRETE PIPE	SD	STORM DRAIN
CSTC	CRUSHED SURFACING TOP COURSE	SDMH	STORMWATER MANHOLE
DIA	DIAMETER	SIM	SIMILAR
DI, DIP	DUCTILE IRON PIPE	SEW	STRUCTURAL EARTH RETAINING WALL
E	EAST, EASTING	SPECS	SPECIFICATIONS
EL	ELEVATION	SPWSD	SAMMAMISH PLATEAU WATER & SEWER DISTRICT
EOA	EDGE OF ASPHALT	SS	SANITARY SEWER
EVCE	END VERTICAL CURB ELEVATION	SSFM	SANITARY SEWER FORCE MAIN
EVCS	END VERTICAL CURB STATION	ST	STEEL
EOG	EDGE OF GRAVEL	STA	STATION
EOP	EDGE OF PAVEMENT	STD	STANDARD
EX, EXIST	EXISTING	TEL	TELEPHONE
FOC	FACE OF CURB	TESC	TEMPORARY EROSION AND SEDIMENT CONTROL
FL	FLANGE, FLOWLINE	TOW	TOP OF WALL
G	GAS	UD	UNDERDRAIN
GB	GRADE BREAK	TYP	TYPICAL
HDPE	HIGH DENSITY POLYETHYLENE PIPE	W, WTR	WATER
HMA	HOT MIX ASPHALT	WS	WATER SERVICE
IE	INVERT ELEVATION	WSDOT	WASHINGTON STATE DEPARTMENT OF TRANSPORTATION
LF	LINEAR FEET	WWM	WELDED WIRE MESH
LP	LOW POINT		
LT	LEFT		
ME	MATCH EXISTING		

DETAIL AND SECTION DESIGNATION

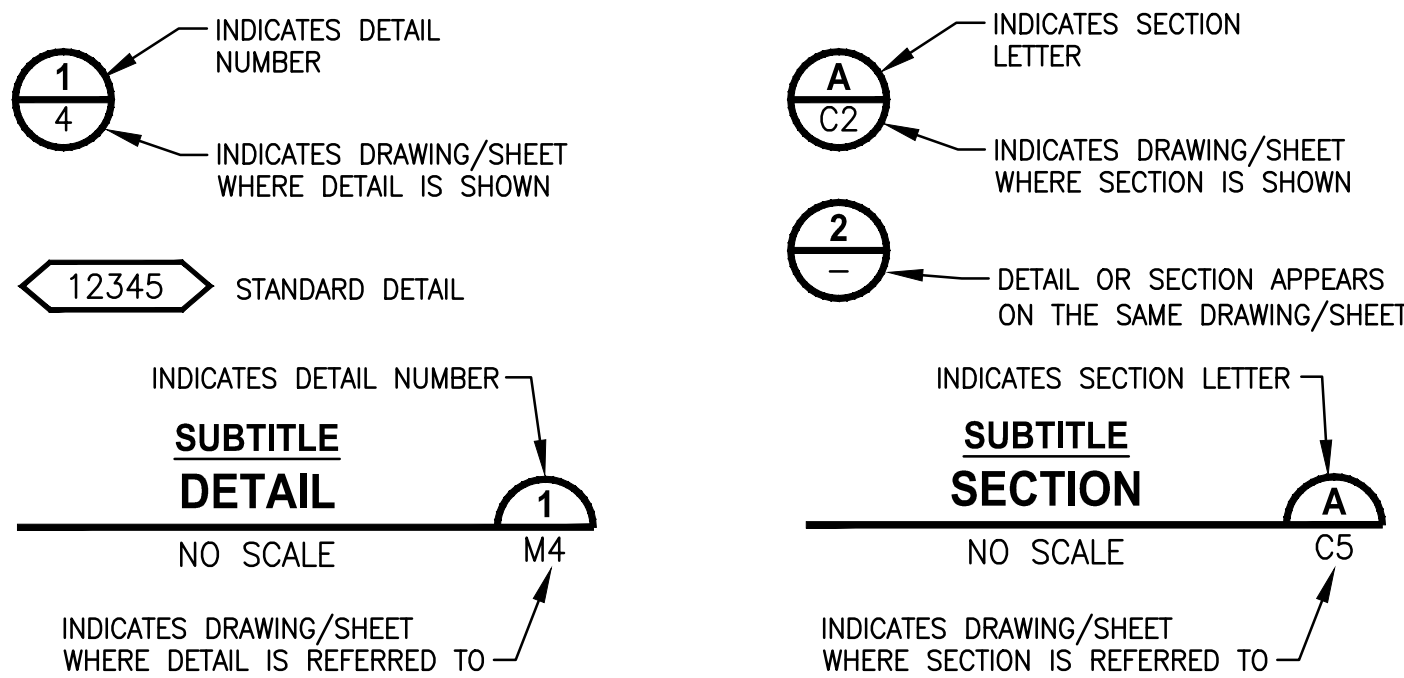

INDEX TO DRAWINGS		
DWG NO.	SHT NO.	SHEET TITLE
GENERAL		
1	G1	COVER SHEET
2	G2	ABBREVIATIONS AND SHEET LIST
3	G3	SHEET INDEX
4	G4	LEGEND
5	G5	SURVEY CONTROL PLAN
6	G6	SURVEY CONTROL PLAN
7	G7	SURVEY CONTROL PLAN
8	G8	SURVEY CONTROL PLAN
9	G9	SURVEY CONTROL SCHEDULE
EXISTING CONDITIONS		
10	EX1	EXISTING CONDITIONS PLAN
11	EX2	EXISTING CONDITIONS PLAN
12	EX3	EXISTING CONDITIONS PLAN
13	EX4	EXISTING CONDITIONS PLAN
14	EX5	EXISTING CONDITIONS PLAN
15	EX6	EXISTING CONDITIONS PLAN
16	EX7	EXISTING CONDITIONS PLAN
17	EX8	EXISTING CONDITIONS PLAN
18	EX9	EXISTING CONDITIONS PLAN
19	EX10	EXISTING CONDITIONS PLAN
20	EX11	EXISTING CONDITIONS PLAN
21	EX12	EXISTING CONDITIONS PLAN
22	EX13	EXISTING CONDITIONS PLAN
23	EX14	EXISTING CONDITIONS PLAN
24	EX15	EXISTING CONDITIONS PLAN
25	EX16	EXISTING CONDITIONS PLAN
26	EX17	EXISTING CONDITIONS PLAN
27	EX18	EXISTING CONDITIONS PLAN
28	EX19	EXISTING CONDITIONS PLAN
29	EX20	EXISTING CONDITIONS PLAN
30	EX21	EXISTING CONDITIONS PLAN
31	EX22	EXISTING CONDITIONS PLAN
TYPICAL CROSS SECTIONS		
32	CS1	TYPICAL CROSS SECTIONS
33	CS2	TYPICAL CROSS SECTIONS
SITE PREPARATION		
34	SP1	SITE PREPARATION PLAN
35	SP2	SITE PREPARATION PLAN
36	SP3	SITE PREPARATION PLAN
37	SP4	SITE PREPARATION PLAN
38	SP5	SITE PREPARATION PLAN
39	SP6	SITE PREPARATION PLAN
40	SP7	SITE PREPARATION PLAN
41	SP8	SITE PREPARATION PLAN
42	SP9	SITE PREPARATION PLAN
43	SP10	SITE PREPARATION PLAN
44	SP11	SITE PREPARATION PLAN
45	SP12	SITE PREPARATION PLAN
46	SP13	SITE PREPARATION PLAN
47	SP14	SITE PREPARATION PLAN
48	SP15	SITE PREPARATION PLAN
49	SP16	SITE PREPARATION PLAN
50	SP17	SITE PREPARATION PLAN
51	SP18	SITE PREPARATION PLAN
52	SP19	SITE PREPARATION PLAN
53	SP20	SITE PREPARATION PLAN
54	SP21	SITE PREPARATION PLAN
55	SP22	SITE PREPARATION PLAN
TESC		
56	TE1	TESC PLAN
57	TE2	TESC PLAN
58	TE3	TESC PLAN
59	TE4	TESC PLAN
60	TE5	TESC PLAN
61	TE6	TESC PLAN
62	TE7	TESC PLAN
63	TE8	TESC PLAN
64	TE9	TESC PLAN
65	TE10	TESC PLAN
66	TE11	TESC PLAN
67	TE12	TESC PLAN
68	TE13	TESC PLAN
69	TE14	TESC PLAN
70	TE15	TESC PLAN
71	TE16	TESC PLAN
72	TE17	TESC PLAN
73	TE18	TESC PLAN
74	TE19	TESC PLAN
75	TE20	TESC PLAN
76	TE21	TESC PLAN
77	TE22	TESC PLAN
TESC DETAILS		
78	TD1	TESC DETAILS
TRAIL PLAN & PROFILE		
79	AL1	PLAN AND PROFILE
80	AL2	PLAN AND PROFILE
81	AL3	PLAN AND PROFILE
82	AL4	PLAN AND PROFILE
83	AL5	PLAN AND PROFILE
84	AL6	PLAN AND PROFILE
85	AL7	PLAN AND PROFILE
86	AL8	PLAN AND PROFILE
87	AL9	PLAN AND PROFILE
88	AL10	PLAN AND PROFILE
89	AL11	PLAN AND PROFILE
90	AL12	PLAN AND PROFILE
91	AL13	PLAN AND PROFILE
92	AL14	PLAN AND PROFILE

INDEX TO DRAWINGS (CONTINUED)		
DWG NO.	SHT NO.	SHEET TITLE
TRAIL PLAN & PROFILE		
93	AL15	PLAN AND PROFILE
94	AL16	PLAN AND PROFILE
95	AL17	PLAN AND PROFILE
96	AL18	PLAN AND PROFILE
97	AL19	PLAN AND PROFILE
98	AL20	PLAN AND PROFILE
99	AL21	PLAN AND PROFILE
100	AL22	PLAN AND PROFILE
101	AL23	PLAN AND PROFILE
102	AL24	PLAN AND PROFILE
103	AL25	PLAN AND PROFILE
104	AL26	PLAN AND PROFILE
105	AL27	PLAN AND PROFILE
106	AL28	PLAN AND PROFILE
107	AL29	PLAN AND PROFILE
108	AL30	PLAN AND PROFILE
109	AL31	PLAN AND PROFILE
110	AL32	PLAN AND PROFILE
111	AL33	PLAN AND PROFILE
112	AL34	PLAN AND PROFILE
113	AL35	PLAN AND PROFILE
114	AL36	PLAN AND PROFILE
115	AL37	PLAN AND PROFILE
116	AL38	PLAN AND PROFILE
117	AL39	PLAN AND PROFILE
118	AL40	PLAN AND PROFILE
UTILITY AND DRAINAGE		
119	UT1	UTILITY AND DRAINAGE PLAN
120	UT2	UTILITY AND DRAINAGE PLAN
121	UT3	UTILITY AND DRAINAGE PLAN
122	UT4	UTILITY AND DRAINAGE PLAN
123	UT5	UTILITY AND DRAINAGE PLAN
124	UT6	UTILITY AND DRAINAGE PLAN
125	UT7	UTILITY AND DRAINAGE PLAN
126	UT8	UTILITY AND DRAINAGE PLAN
127	UT9	UTILITY AND DRAINAGE PLAN
128	UT10	UTILITY AND DRAINAGE PLAN
129	UT11	UTILITY AND DRAINAGE PLAN
130	UT12	UTILITY AND DRAINAGE PLAN
131	UT13	UTILITY AND DRAINAGE PLAN
132	UT14	UTILITY AND DRAINAGE PLAN
133	UT15	UTILITY AND DRAINAGE PLAN
134	UT16	UTILITY AND DRAINAGE PLAN
135	UT17	UTILITY AND DRAINAGE PLAN
136	UT18	UTILITY AND DRAINAGE PLAN
137	UT19	UTILITY AND DRAINAGE PLAN
138	UT20	UTILITY AND DRAINAGE PLAN
139	UT21	UTILITY AND DRAINAGE PLAN
140	UT22	UTILITY AND DRAINAGE PLAN
141	UT23	UTILITY AND DRAINAGE PLAN
142	UT24	UTILITY AND DRAINAGE PLAN
143	UT25	UTILITY AND DRAINAGE PLAN
STORM DRAIN PROFILES		
144	SD1	STORM DRAIN PROFILES AND SECTIONS
145	SD2	STORM DRAIN PROFILES AND SECTIONS
146	SD3	STORM DRAIN PROFILES AND SECTIONS
147	SD4	STORM DRAIN PROFILES AND SECTIONS
148	SD5	STORM DRAIN PROFILES AND SECTIONS
149	SD6	STORM DRAIN PROFILES AND SECTIONS
150	SD7	STORM DRAIN PROFILES AND SECTIONS
151	SD8	STORM DRAIN PROFILES AND SECTIONS
152	SD9	STORM DRAIN PROFILES AND SECTIONS
153	SD10	STORM DRAIN PROFILES AND SECTIONS
154	SD11	STORM DRAIN PROFILES AND SECTIONS
155	SD12	STORM DRAIN PROFILES AND SECTIONS
DRAINAGE DETAILS		
156	DD1	DRAINAGE DETAILS
157	DD2	DRAINAGE DETAILS
158	DD3	DRAINAGE DETAILS
FISH PASSAGE CULVERTS		
159	FP1	FISH PASSAGE CULVERTS
160	FP2	FISH PASSAGE CULVERTS
161	FP3	FISH PASSAGE CULVERTS
162	FP4	FISH PASSAGE CULVERTS
163	FP5	FISH PASSAGE CULVERTS
164	FP6	FISH PASSAGE CULVERTS
165	FP7	FISH PASSAGE CULVERTS
166	FP8	FISH PASSAGE CULVERTS
167	FP9	FISH PASSAGE CULVERTS
168	FP10	FISH PASSAGE CULVERTS
169	FP11	FISH PASSAGE CULVERTS
DRIVEWAY PLAN AND PROFILE		
170	DP1	DRIVEWAY PLAN AND PROFILE
171	DP2	DRIVEWAY PLAN AND PROFILE
172	DP3	DRIVEWAY PLAN AND PROFILE
173	DP4	DRIVEWAY PLAN AND PROFILE
174	DP5	DRIVEWAY PLAN AND PROFILE
175	DP6	DRIVEWAY PLAN AND PROFILE
176	DP7	DRIVEWAY PLAN AND PROFILE
177	DP8	DRIVEWAY PLAN AND PROFILE
178	DP9	DRIVEWAY PLAN AND PROFILE
179	DP10	DRIVEWAY PLAN AND PROFILE
180	DP11	DRIVEWAY PLAN AND PROFILE
181	DP12	DRIVEWAY PLAN AND PROFILE
182	DP13	DRIVEWAY PLAN AND PROFILE
183	DP14	DRIVEWAY PLAN AND PROFILE
184	DP15	DRIVEWAY PLAN AND PROFILE
185	DP16	DRIVEWAY PLAN AND PROFILE

INDEX TO DRAWINGS (CONTINUED)		
DWG NO.	SHT NO.	SHEET TITLE
DRIVEWAY PLAN AND PROFILE		
186	DP17	DRIVEWAY PLAN AND PROFILE
187	DP18	DRIVEWAY PLAN AND PROFILE
188	DP19	DRIVEWAY PLAN AND PROFILE
189	DP20	DRIVEWAY PLAN AND PROFILE
190	DP21	DRIVEWAY PLAN AND PROFILE
191	DP22	DRIVEWAY PLAN AND PROFILE
192	DP23	DRIVEWAY PLAN AND PROFILE
193	DP24	DRIVEWAY PLAN AND PROFILE
WALL PROFILES		
194	WP1	WALL PROFILES
195	WP2	WALL PROFILES
196	WP3	WALL PROFILES
197	WP4	WALL PROFILES
198	WP5	WALL PROFILES
199	WP6	WALL PROFILES
200	WP7	WALL PROFILES
201	WP8	WALL PROFILES
202	WP9	WALL PROFILES
203	WP10	WALL PROFILES
WALL DETAILS		
204	WD1	STRUCTURAL EARTH WALL DETAILS
205	WD2	STRUCTURAL EARTH WALL DETAILS
206	WD3	STRUCTURAL EARTH WALL SCHEDULE
STRUCTURE		
207	S1	WALL #3A SOLDIER PILE WALL
208	S2	WALL #3A SOLDIER PILE WALL
209	S3	WALL #6 SOLDIER PILE WALL
210	S4	WALL #6 SOLDIER PILE WALL
211	S5	SOLDIER PILE WALL DETAILS
212	S6	SOLDIER PILE WALL DETAILS
213	S7	CIP CONCRETE STAIR DETAILS
214	S8	CIP CONCRETE STAIR DETAILS
PAVEMENT MARKING & SIGNING		
215	PS1	PAVEMENT MARKING AND SIGNING PLAN
216	PS2	PAVEMENT MARKING AND SIGNING PLAN
217	PS3	PAVEMENT MARKING AND SIGNING PLAN
218	PS4	PAVEMENT MARKING AND SIGNING PLAN
219	PS5	PAVEMENT MARKING AND SIGNING PLAN
220	PS6	PAVEMENT MARKING AND SIGNING PLAN
221	PS7	PAVEMENT MARKING AND SIGNING PLAN
222	PS8	PAVEMENT MARKING AND SIGNING PLAN
223	PS9	PAVEMENT MARKING AND SIGNING PLAN
224	PS10	PAVEMENT MARKING AND SIGNING PLAN
225	PS11	PAVEMENT MARKING AND SIGNING PLAN
226	PS12	PAVEMENT MARKING AND SIGNING PLAN
227	PS13	PAVEMENT MARKING AND SIGNING PLAN
228	PS14	PAVEMENT MARKING AND SIGNING PLAN
229	PS15	PAVEMENT MARKING AND SIGNING PLAN
230	PS16	PAVEMENT MARKING AND SIGNING PLAN
231	PS17	PAVEMENT MARKING AND SIGNING PLAN
232	PS18	PAVEMENT MARKING AND SIGNING PLAN
233	PS19	PAVEMENT MARKING AND SIGNING PLAN
234	PS20	PAVEMENT MARKING AND SIGNING PLAN
235	PS21	PAVEMENT MARKING AND SIGNING PLAN
236	PS22	SIGN SCHEDULE
MISCELLANEOUS DETAILS		
237	MD1	MISCELLANEOUS DETAILS
238	MD2	MISCELLANEOUS DETAILS
239	MD3	MISCELLANEOUS DETAILS
240	MD4	MISCELLANEOUS DETAILS
241	MD5	MISCELLANEOUS DETAILS
242	MD6	MISCELLANEOUS DETAILS
243	MD7	MISCELLANEOUS DETAILS
244	MD8	MISCELLANEOUS DETAILS
245	MD9	MISCELLANEOUS DETAILS
LANDSCAPE		
246	LA1	LANDSCAPE PLAN
247	LA2	LANDSCAPE PLAN
248	LA3	LANDSCAPE PLAN
249	LA4	LANDSCAPE PLAN
250	LA5	LANDSCAPE PLAN
251	LA6	LANDSCAPE PLAN
252	LA7	LANDSCAPE PLAN
253	LA8	LANDSCAPE PLAN
254	LA9	LANDSCAPE PLAN
255	LA10	LANDSCAPE PLAN
256	LA11	LANDSCAPE PLAN
257	LA12	LANDSCAPE PLAN
258	LA13	LANDSCAPE PLAN
259	LA14	LANDSCAPE PLAN
260	LA15	LANDSCAPE PLAN
261	LA16	LANDSCAPE PLAN
262	LA17	LANDSCAPE PLAN
263	LA18	LANDSCAPE PLAN
264	LA19	LANDSCAPE PLAN
265	LA20	LANDSCAPE PLAN
266	LA21	LANDSCAPE PLAN
267	LA22	LANDSCAPE PLAN
268	LA23	LANDSCAPE PLAN
MITIGATION DETAILS AND NOTES		
269	LD1	STREAM PLANTING PLAN DETAIL
270	LD2	STREAM PLANTING PLAN DETAIL
271	LD3	PLANTING SCHEDULE
272	LD4	PLANTING SCHEDULE
273	LD5	MITIGATION NOTES
274	LD6	MITIGATION NOTES

CITY OF SAMMAMISH APPROVAL	
City Engineer	Date
Community Development	Date

90 % REVIEW SUBMITTAL
NOT FOR CONSTRUCTION


REVISIONS	DATE	BY	DESIGNED
			M. TSUN
			DRAWN B. PURGANAN
			CHECKED Y. HO
			APPROVED J. BAILEY

ONE INCH AT FULL SCALE.
IF NOT, SCALE ACCORDINGLY.

FILE NAME
BL1521075P19T03G-02

JOB No.
554-1521-075 P19 T03

DATE
FEBRUARY 2019

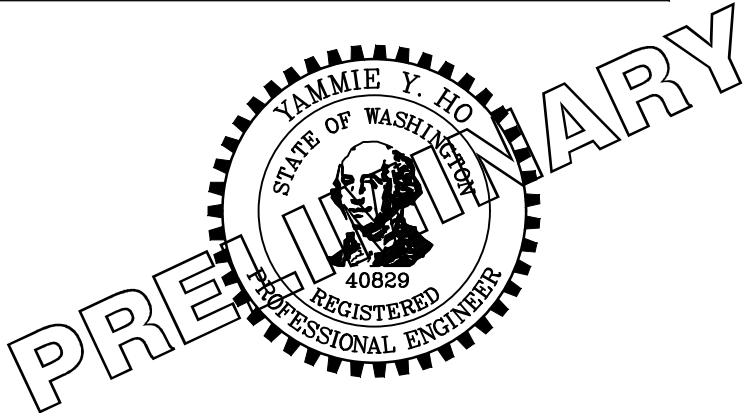

Parametrix
ENGINEERING · PLANNING · ENVIRONMENTAL SCIENCES

719 2ND AVENUE, SUITE 200 | SEATTLE, WA 98104
P 206.394.3700
WWW.PARAMETRIX.COM

PROJECT NAME


EAST LAKE SAMMAMISH
MASTER PLAN TRAIL
SOUTH SAMMAMISH SEGMENT B
SAMMAMISH, WA

ABBREVIATIONS AND SHEET LIST

SHEET NO.
2 OF 274

G2

LAYOUT: G3 PATH: U:\PSO\Projects\Clients\1521-KingCo\554-1521-075-ELST\995\cs\CA00\Phase 19\T03 Civil\Draw\ PLOTTED BY: purgubut DATE: Wednesday, February 27, 2019 6:44:54 PM

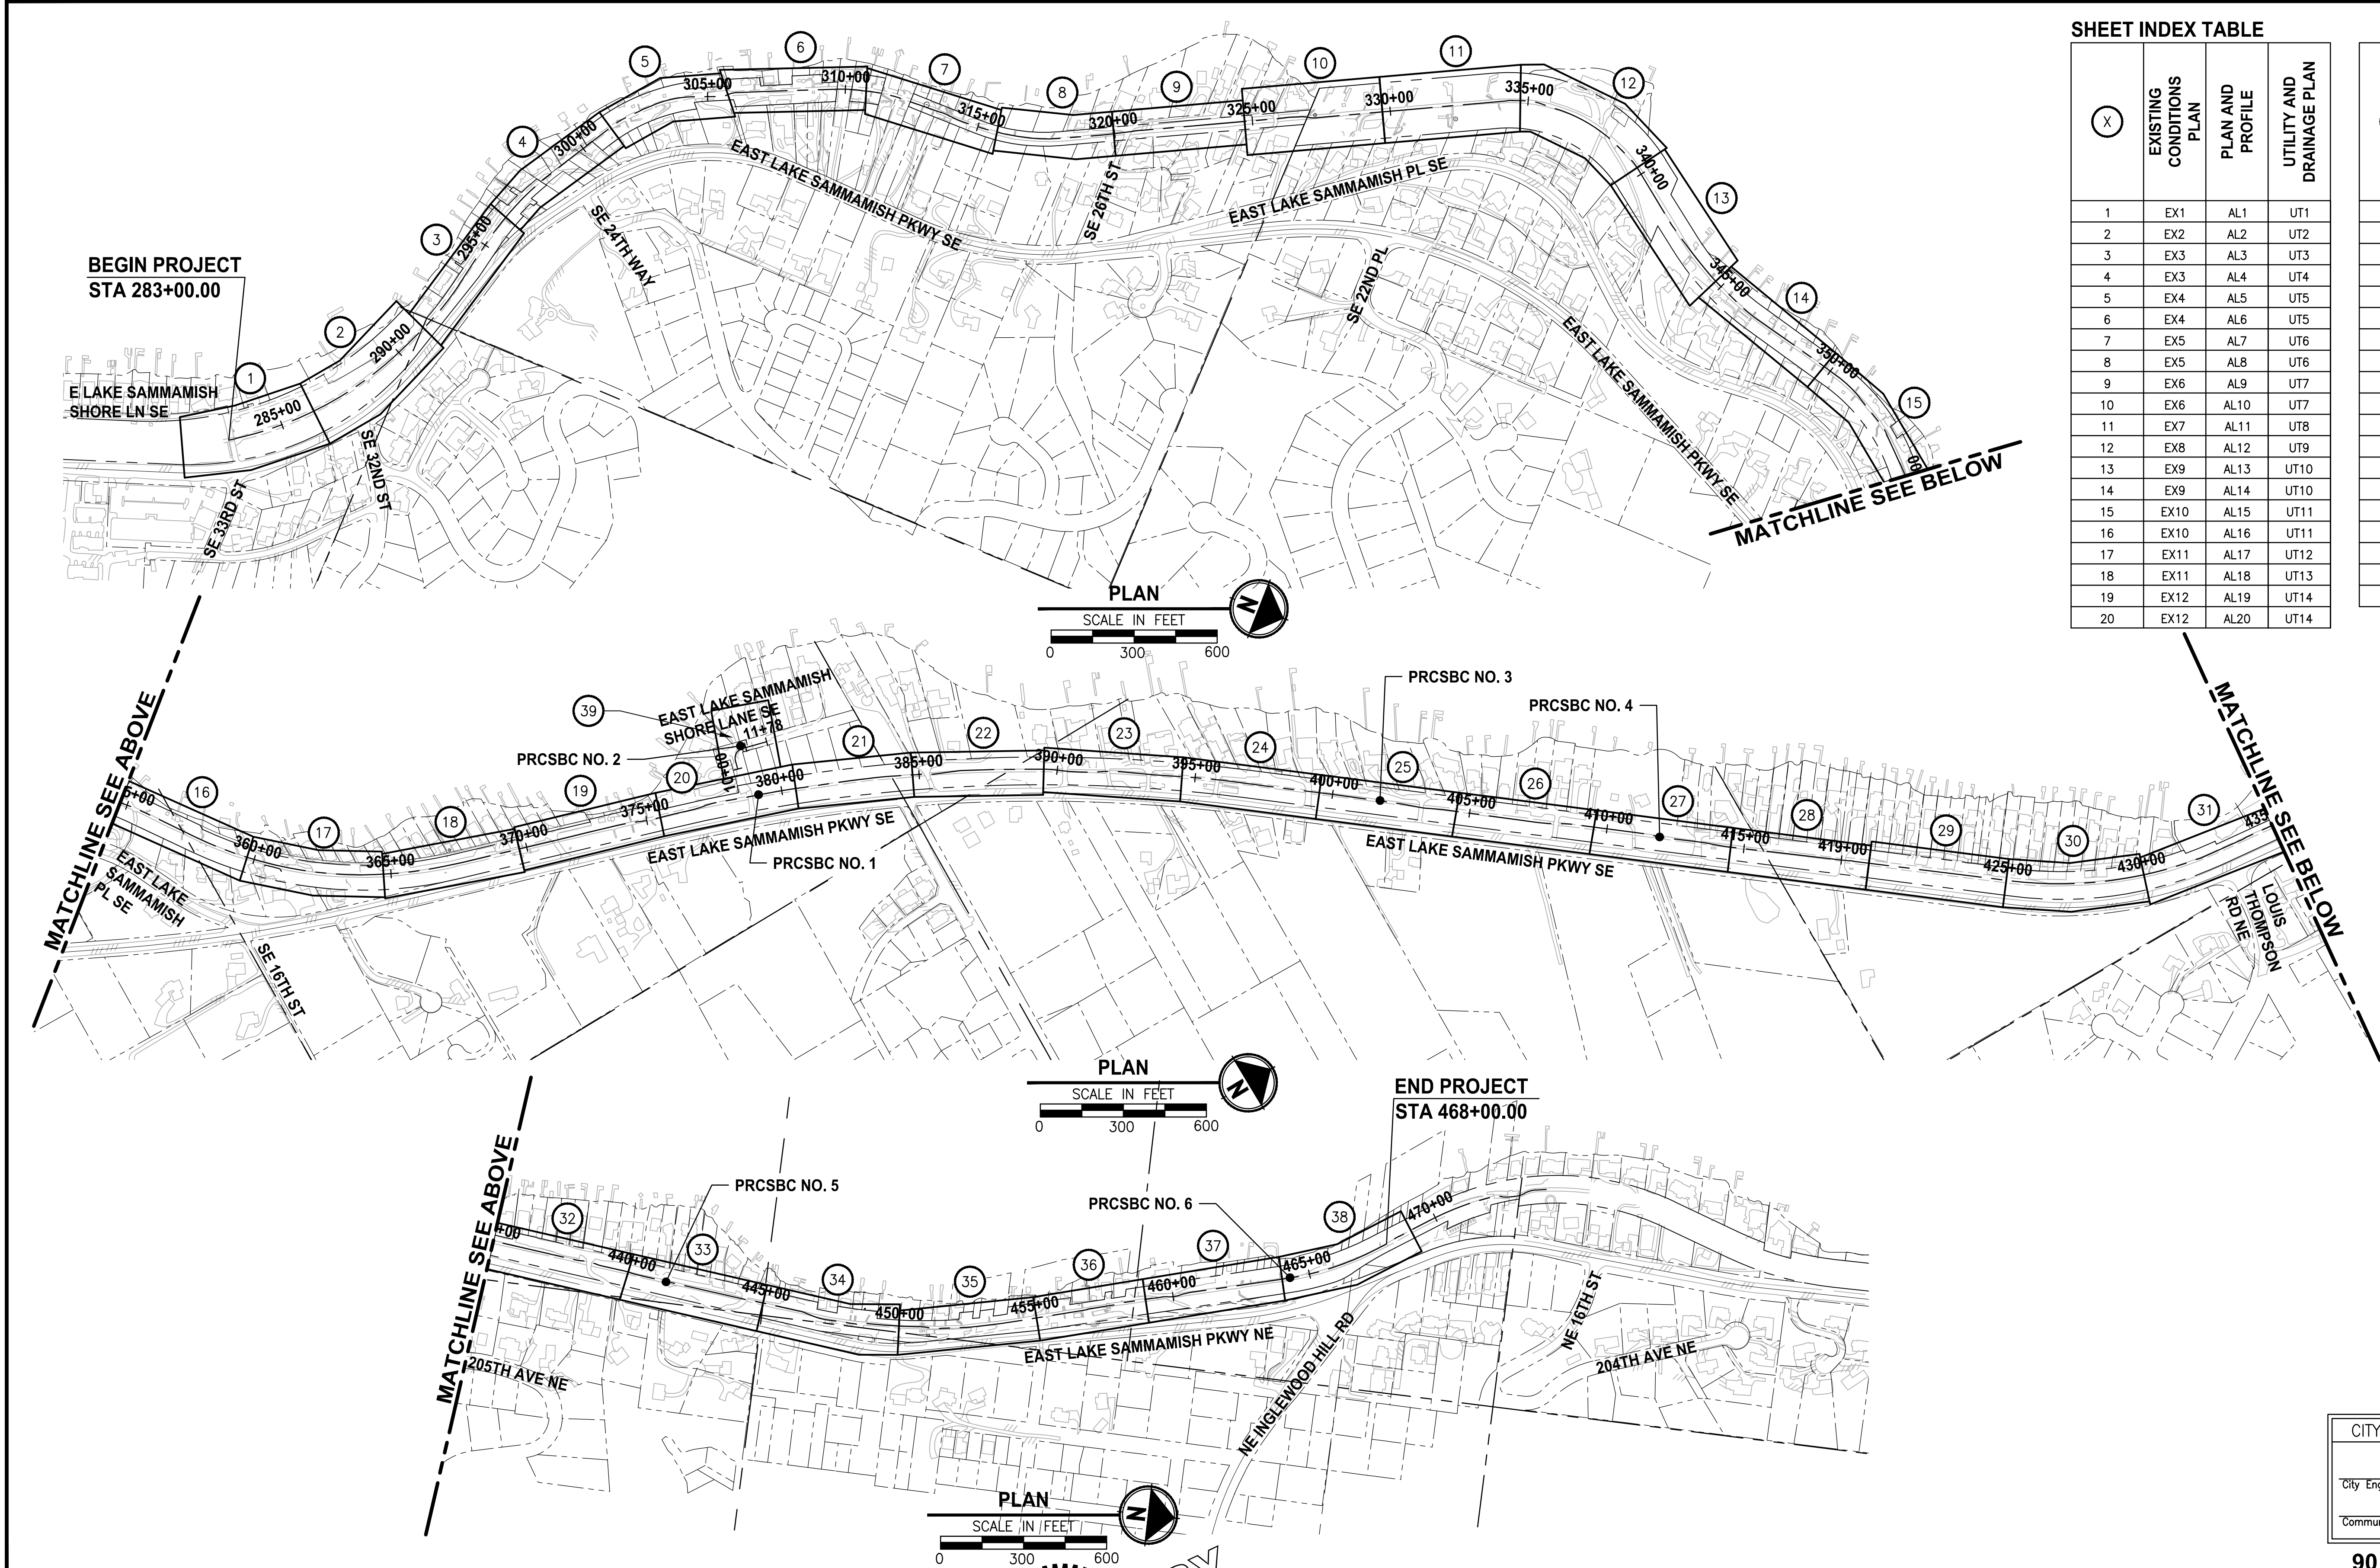

SHEET INDEX TABLE

(X)	EXISTING CONDITIONS PLAN	PLAN AND PROFILE	UTILITY AND DRAINAGE PLAN
1	EX1	AL1	UT1
2	EX2	AL2	UT2
3	EX3	AL3	UT3
4	EX3	AL4	UT4
5	EX4	AL5	UT5
6	EX4	AL6	UT5
7	EX5	AL7	UT6
8	EX5	AL8	UT6
9	EX6	AL9	UT7
10	EX6	AL10	UT7
11	EX7	AL11	UT8
12	EX8	AL12	UT9
13	EX9	AL13	UT10
14	EX9	AL14	UT10
15	EX10	AL15	UT11
16	EX10	AL16	UT11
17	EX11	AL17	UT12
18	EX11	AL18	UT13
19	EX12	AL19	UT14
20	EX12	AL20	UT14

(X)	EXISTING CONDITIONS PLAN	PLAN AND PROFILE	UTILITY AND DRAINAGE PLAN
21	EX13	AL21	UT15
22	EX13	AL22	UT15
23	EX14	AL23	UT16
24	EX14	AL24	UT16
25	EX15	AL25	UT17
26	EX15	AL26	UT17
27	EX16	AL27	UT18
28	EX16	AL28	UT18
29	EX17	AL29	UT19
30	EX17	AL30	UT19
31	EX18	AL31	UT20
32	EX18	AL32	UT21
33	EX19	AL33	UT22
34	EX19	AL34	UT22
35	EX20	AL35	UT23
36	EX20	AL36	UT23
37	EX21	AL37	UT24
38	EX21	AL38	UT24
39	EX22	AL39	UT25

CITY OF SAMMAMISH APPROVAL	
City Engineer	Date
Community Development	Date

90 % REVIEW SUBMITTAL
NOT FOR CONSTRUCTION


REVISIONS	DATE	BY	DESIGNED M. TSUN
			DRAWN B. PURGANAN
			CHECKED Y. HO
			APPROVED J. BAILEY

ONE INCH AT FULL SCALE.
IF NOT, SCALE ACCORDINGLY

FILE NAME
BL1521075P19T03G-03

JOB No.
554-1521-075 P19 T03

DATE
FEBRUARY 2019

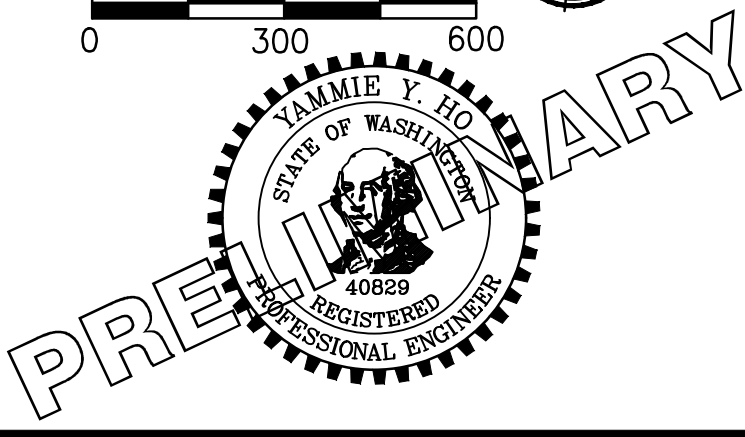

Parametrix
ENGINEERING · PLANNING · ENVIRONMENTAL SCIENCES

719 2ND AVENUE, SUITE 200 | SEATTLE, WA 98104
P 206.394.3700
WWW.PARAMETRIX.COM

PROJECT NAME

**EAST LAKE SAMMAMISH
MASTER PLAN TRAIL
SOUTH SAMMAMISH SEGMENT B**

SAMMAMISH, WA

SHEET INDEX

SHEET NO.
3 OF 274

G3

LAYOUT: G4 PATH: U:\PSO\Projects\Clients\1521-KingCo\554-1521-075-ELST\995vcs\CADD\Phase 19\T03 Civil\DWG\ PLOTTED BY: purgabut DATE: Wednesday, February 27, 2019 6:45:02 PM



LEGEND

DESCRIPTION

PROPOSED

EXISTING

RIGHT OF WAY
PROPERTY LINE
RR LEASE LINE
SECTION LINE
QUARTER SECTION LINE
FOUND MONUMENTS
REBAR & CAP
HUB & TACK
PK NAIL
FOUND MAG NAIL
SET MAG NAIL
PROPERTY CORNER
EASEMENT LINE/
DRAINAGE CONVEYANCE AREA
STREAM BUFFER
STREAM
EDGE OF WATER
WETLAND FLAG
WETLAND BUFFER
ORDINARY HIGH WATER MARK
FLOODWAY BOUNDARY
SHORELINE
50' SHORELINE SETBACK
200' SHORELINE SETBACK
DITCH
JURISDICTIONAL DITCH
CENTERLINE & EDGES
TEMPORARY EXCAVATION LIMIT
UNDERDRAIN TRENCH
SOLID WALL PVC
TEMPORARY DRAIN PIPE
STORM DRAIN
STORM DRAIN (PER RECORD INFO)
CULVERT/STORM DRAIN PIPE
QUARRY SPALL/RIP RAP
INFILTRATION TRENCH
CATCH BASIN, TYPE 1
CATCH BASIN, TYPE 2
CATCH BASIN W/ SOLID LID
INLET PROTECTION
SANITARY SEWER LINE
SANITARY SEWER LINE (PER RECORD INFO)
SANITARY SEWER MANHOLE
SANITARY SEWER VALVE
SANITARY SEWER VAULT
CLEANOUT
CONTOURS MAJOR
CONTOURS MINOR
HIGH VISIBILITY SILT FENCE
HIGH VISIBILITY FENCE
CLEARING AND GRUBBING LIMITS
CLEARING LIMITS
MITIGATION CLEARING
FILL LINE
CUT LINE
SAWCUT
ASPHALT EDGE
CONCRETE LINE
CURB AND GUTTER
EDGE OF GRAVEL

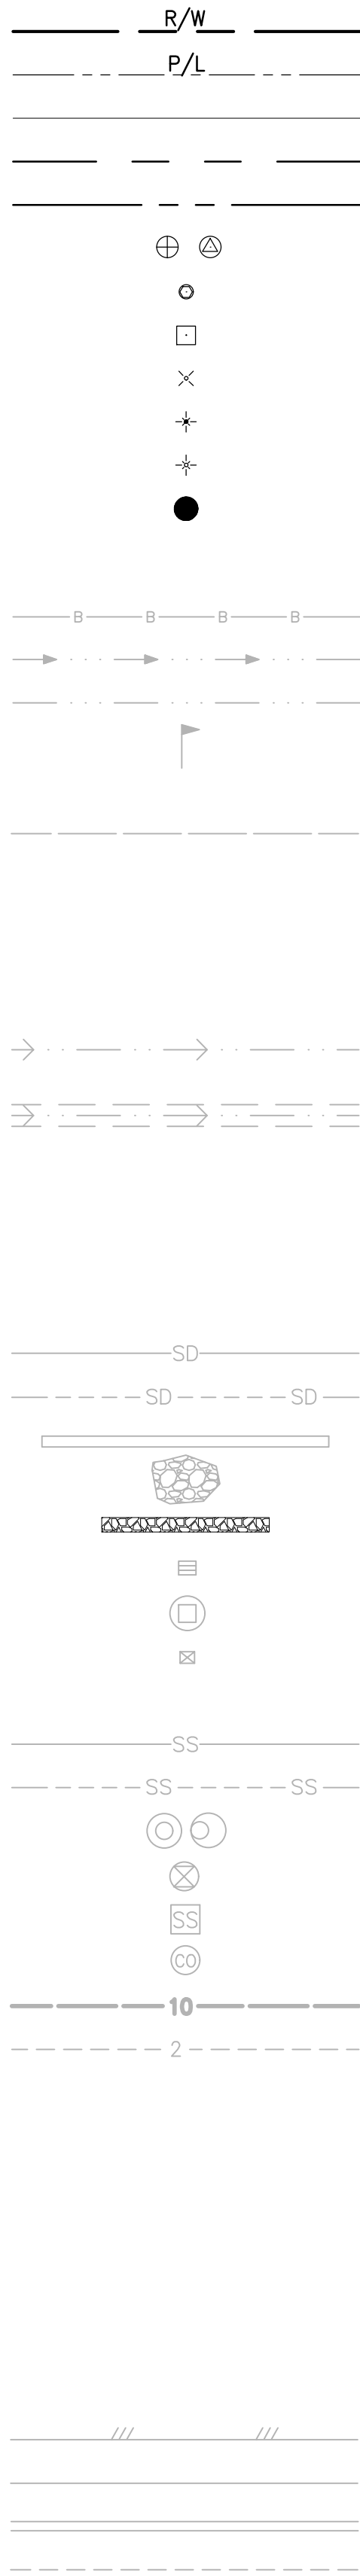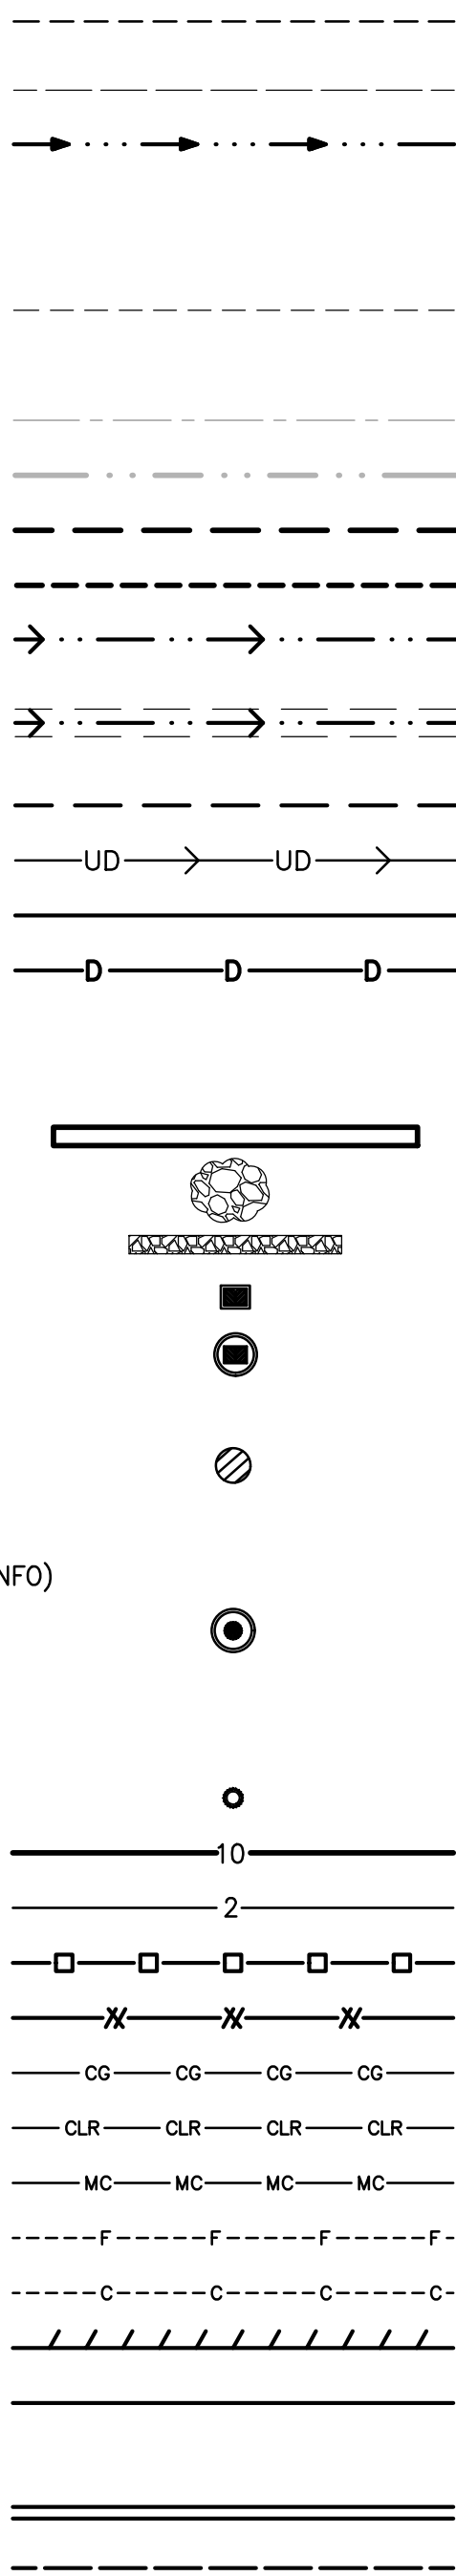


LEGEND

DESCRIPTION

PROPOSED

EXISTING

BARBWIRE FENCE
SPLIT RAIL FENCE
BOARD FENCE
TWO-RAIL FENCE
CHAIN LINK FENCE
TEMPORARY SAFETY FENCE
HOG WIRE FENCE
WOOD GUARDRAIL
GUY ANCHOR
POWER POLE WITH LIGHT
FLOOD LIGHT
UTILITY POLE
PP W/ UG DROP
PP W/ UG DROP & XMFR
PP W/ XMFR
OVERHEAD POWER AND/OR TELECOM
OVERHEAD POWER (PER RECORD INFO)
POWER
POWER (PER RECORD INFO)
POWER VAULT
POWER TRANSFORMER
POWER MANHOLE
POWER HANDHOLE
POWER CABINET
POWER RISER
POWER METER
SOLID LID J-BOX
STAND PIPE / HOSE BIB
LUMINAIRE
TELEPHONE VAULT
TELEPHONE RISER
TELEPHONE MANHOLE
TELEPHONE/COMMUNICATION
TELEPHONE/COMMUNICATION (PER RECORD INFO)
TV RISER
TV
GAS VALVE
GAS METER
GAS
GAS (PER RECORD INFO)
WATER LINE
WATER LINE (PER RECORD INFO)
FIRE HYDRANT
WATER METER
WATER VALVE
WATER VAULT
MONITORING WELL OR ARTESIAN WELL
AREA DRAIN
ROOF DRAIN
WATER BLOW OFF VALVE
WATER POST INDICATOR
SPRINKLER HEAD ROT=90
IRRIGATION CONTROL VALVE
FLOW DIRECTION
PROPERTY PARCEL NUMBER

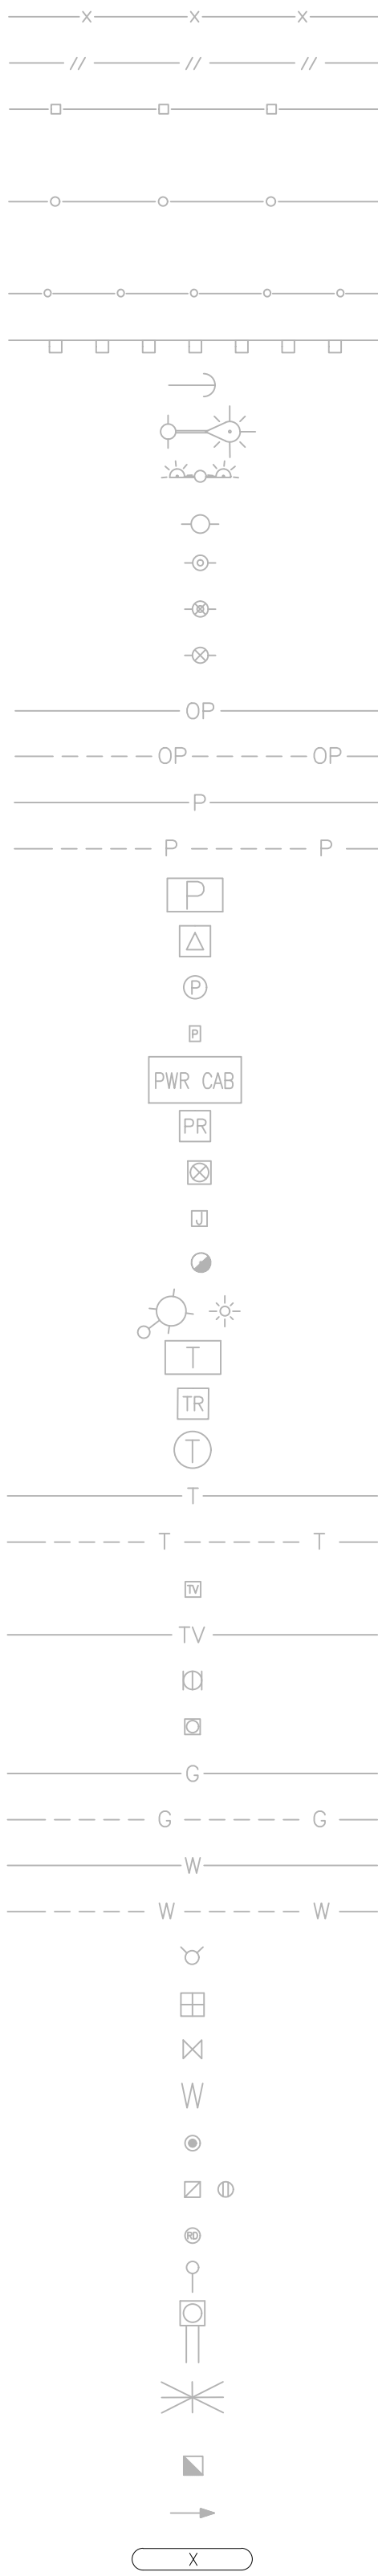



LEGEND

DESCRIPTION

PROPOSED

EXISTING

TRAFFIC SIGNAL POLE W/ LAMP
TRAFFIC SIGNAL POLE
TRAFFIC CONTROL LOOP (SQ)
TRAFFIC CONTROL CABINET
PEDESTRIAN POLE
SAMPLE PLOT
SURFACE POST
SIGN
SKIP LANE LINE
SOLID LANE LINE
FOG LINE
LTO ARROW
STO ARROW
RTO ARROW
MAILBOX
DECIDUOUS TREE
CONIFEROUS TREE
WETLAND SYMBOL
WETLAND BOUNDARY
VEGETATION
STRUCTURAL EARTH WALL
SOLDIER PILE WALL
ROCK WALL
HANDICAPPED SYMBOL
WHEELCHAIR RAMP
BUILDING LINE
CONCRETE STAIR LINE
WOOD STAIRWAY
REMOVE ASPHALT
PATTERNED CONCRETE INTERSECTION
SLOPE PROTECTION
SANDBAG DAM
CHECK DAM
WATTLE CHECK DAM
FORMER RAILROAD CENTERLINE
CONSTRUCTION CENTERLINE

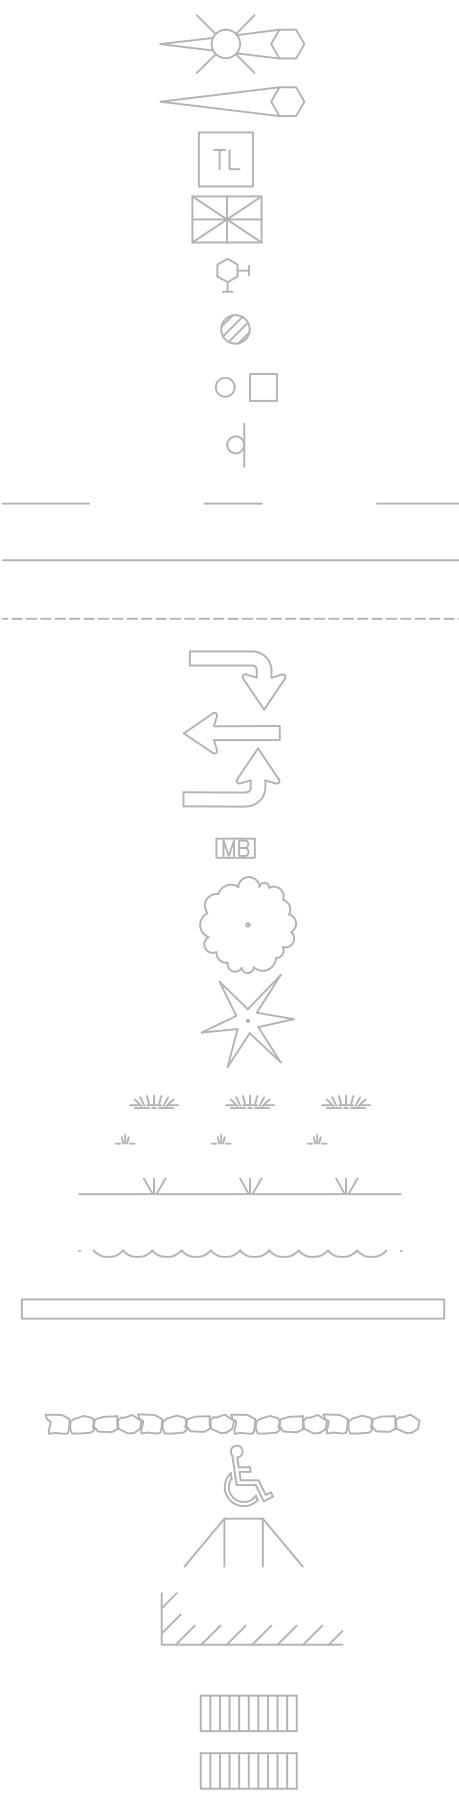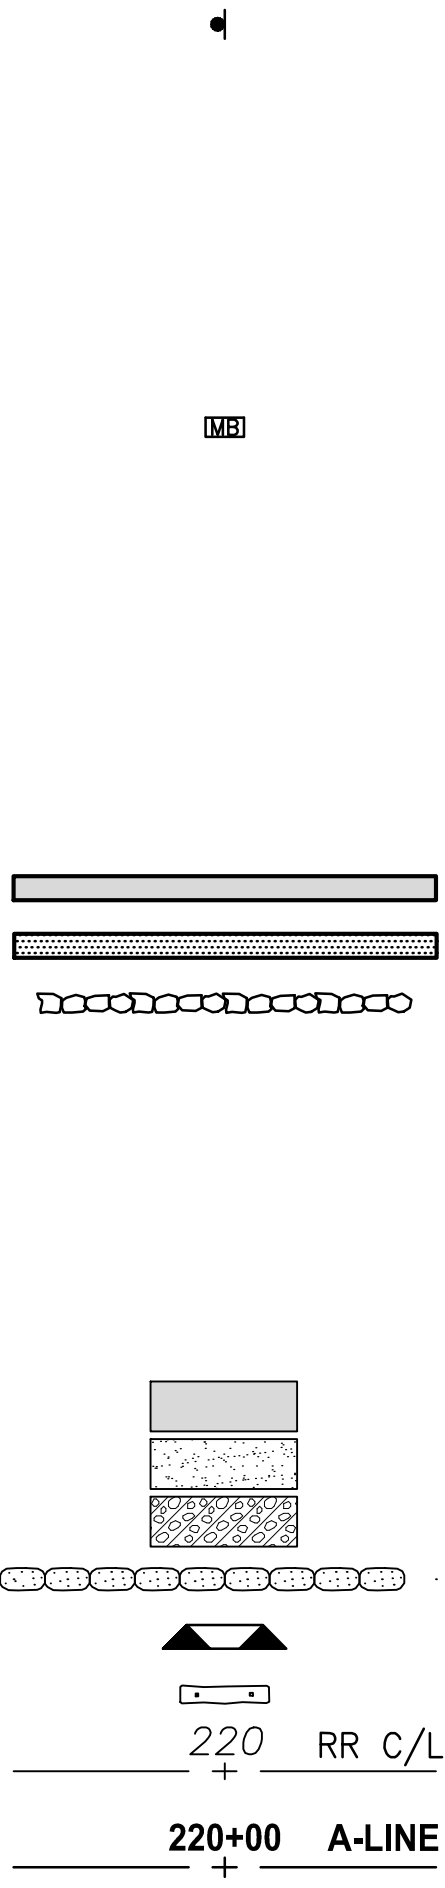

CITY OF SAMMAMISH APPROVAL	
City Engineer	Date
Community Development	Date

90 % REVIEW SUBMITTAL
NOT FOR CONSTRUCTION


LEGEND

SHEET NO.
4 OF 274

G4

ONE INCH AT FULL SCALE.
IF NOT, SCALE ACCORDINGLY

FILE NAME
BL1521075P19T03G-04
JOB No.
554-1521-075 P19 T03
DATE
FEBRUARY 2019

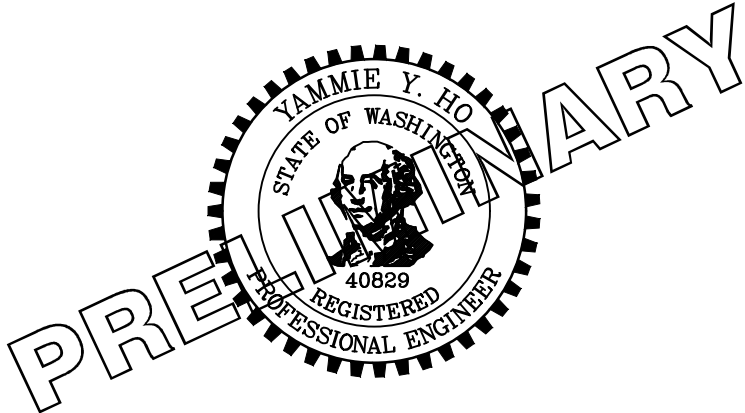

Parametrix

ENGINEERING . PLANNING . ENVIRONMENTAL SCIENCES

719 2ND AVENUE, SUITE 200 | SEATTLE, WA 98104
P 206.394.3700
WWW.PARAMETRIX.COM

PROJECT NAME

EAST LAKE SAMMAMISH
MASTER PLAN TRAIL
SOUTH SAMMAMISH SEGMENT B
SAMMAMISH, WA